



 
VIEW B

VUE B

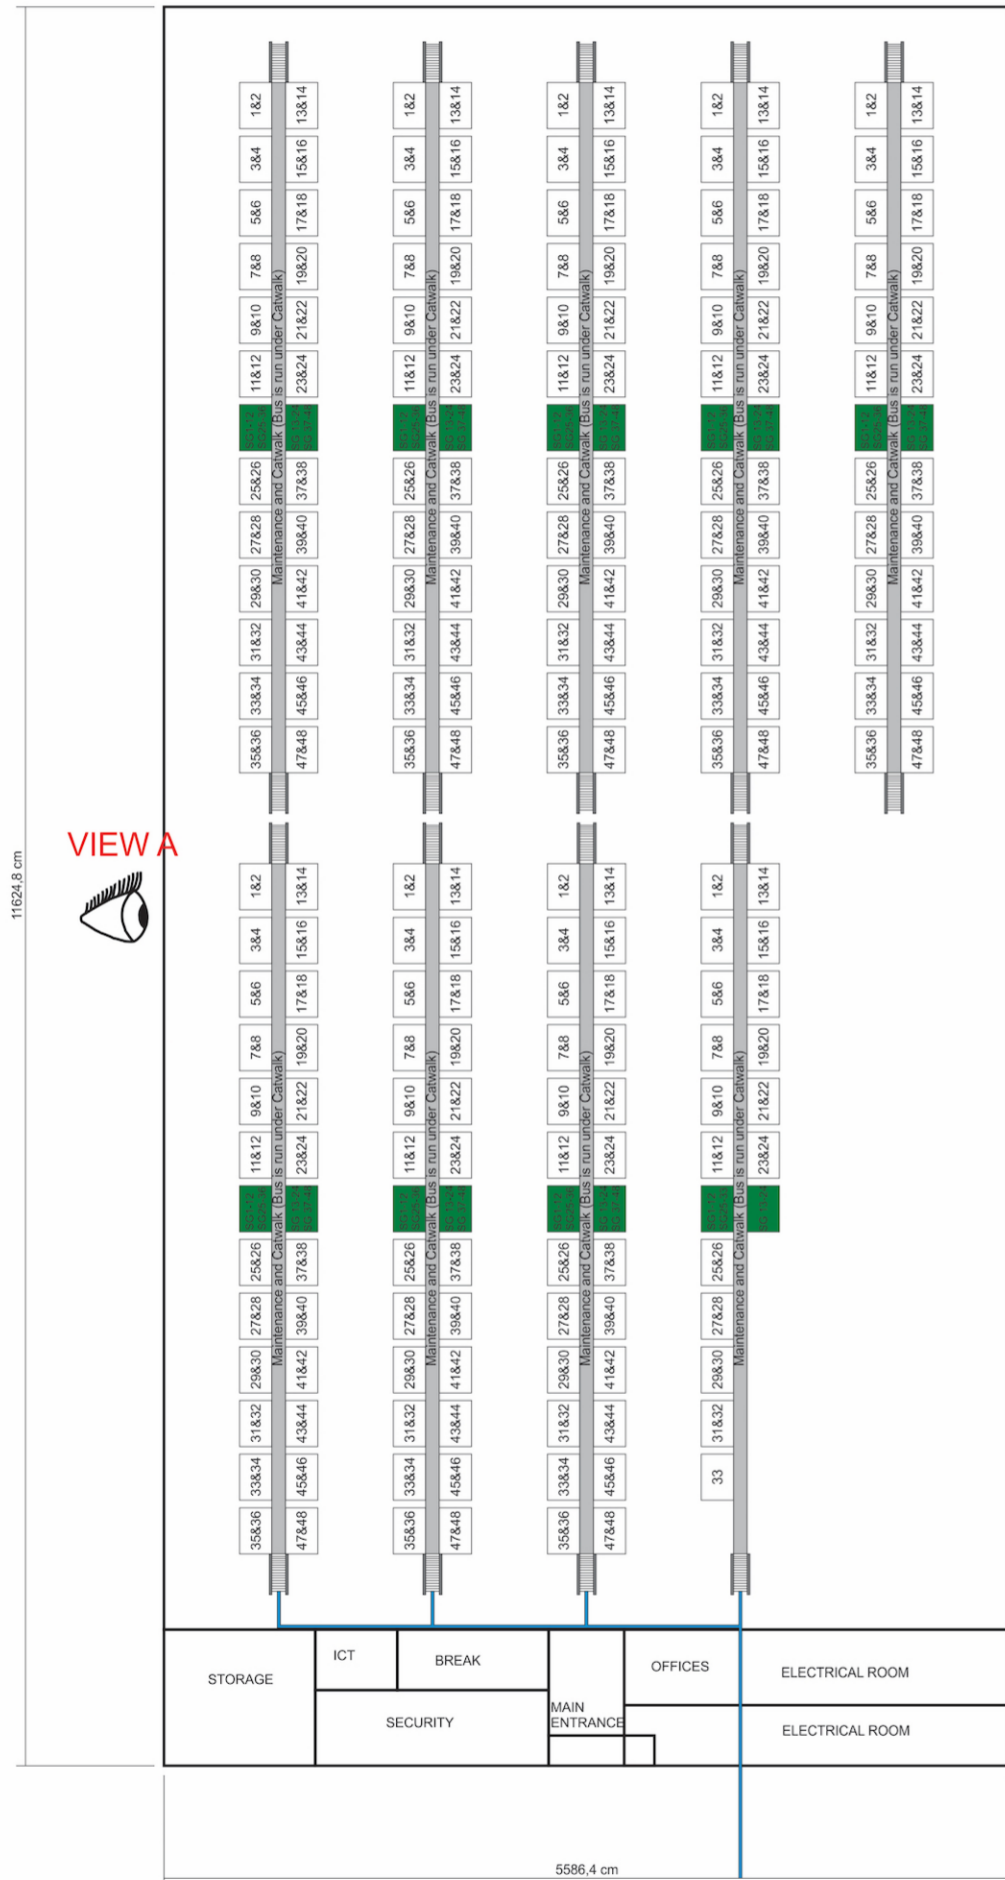

VUE A

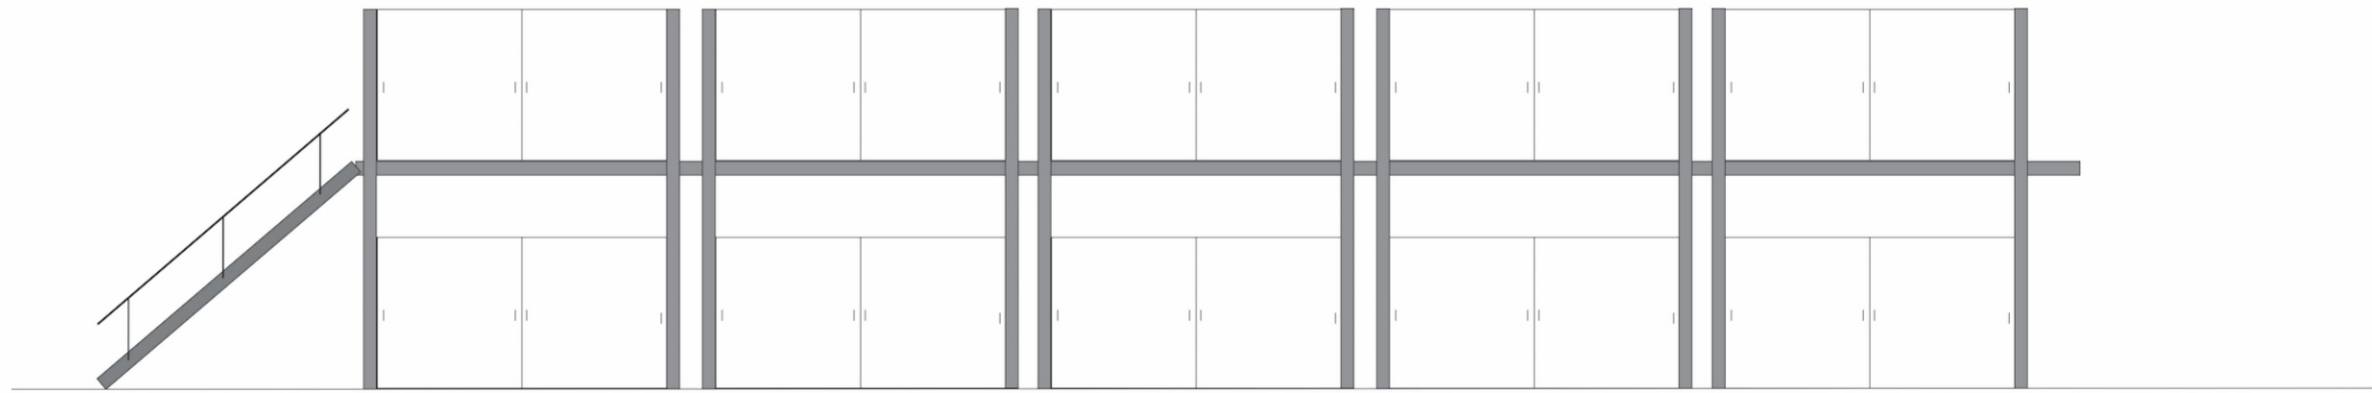

60	7 per Container	417	25.02	7000	11000
Containers	Hybrid Generators (HG)	Total HG	MW	Surface Plant (m²)	Surface Site (m²)
Drawing Number: D02502	Scale: 1:250	Version: 23	Date: 23-02-2018		
Project Number: 2017 EPHG 02502			Date: 12-09-2017		
Authorized & Approved Developer EPC Contractor: ANDO ENERGY s.r.l.		 Huddevettersstraat 67 3030 Houtstade Belgium Tel: +32 477 313 881 Email: antonio.scarpone@ando-energy.com			
Country: BURUNDI	Location: Bujumbura		Geographic Coordinates 00° 00' 00" E/ 00° 00' 00" N		
Project: Electrical Plant Hybrid Generators 25 MW					